


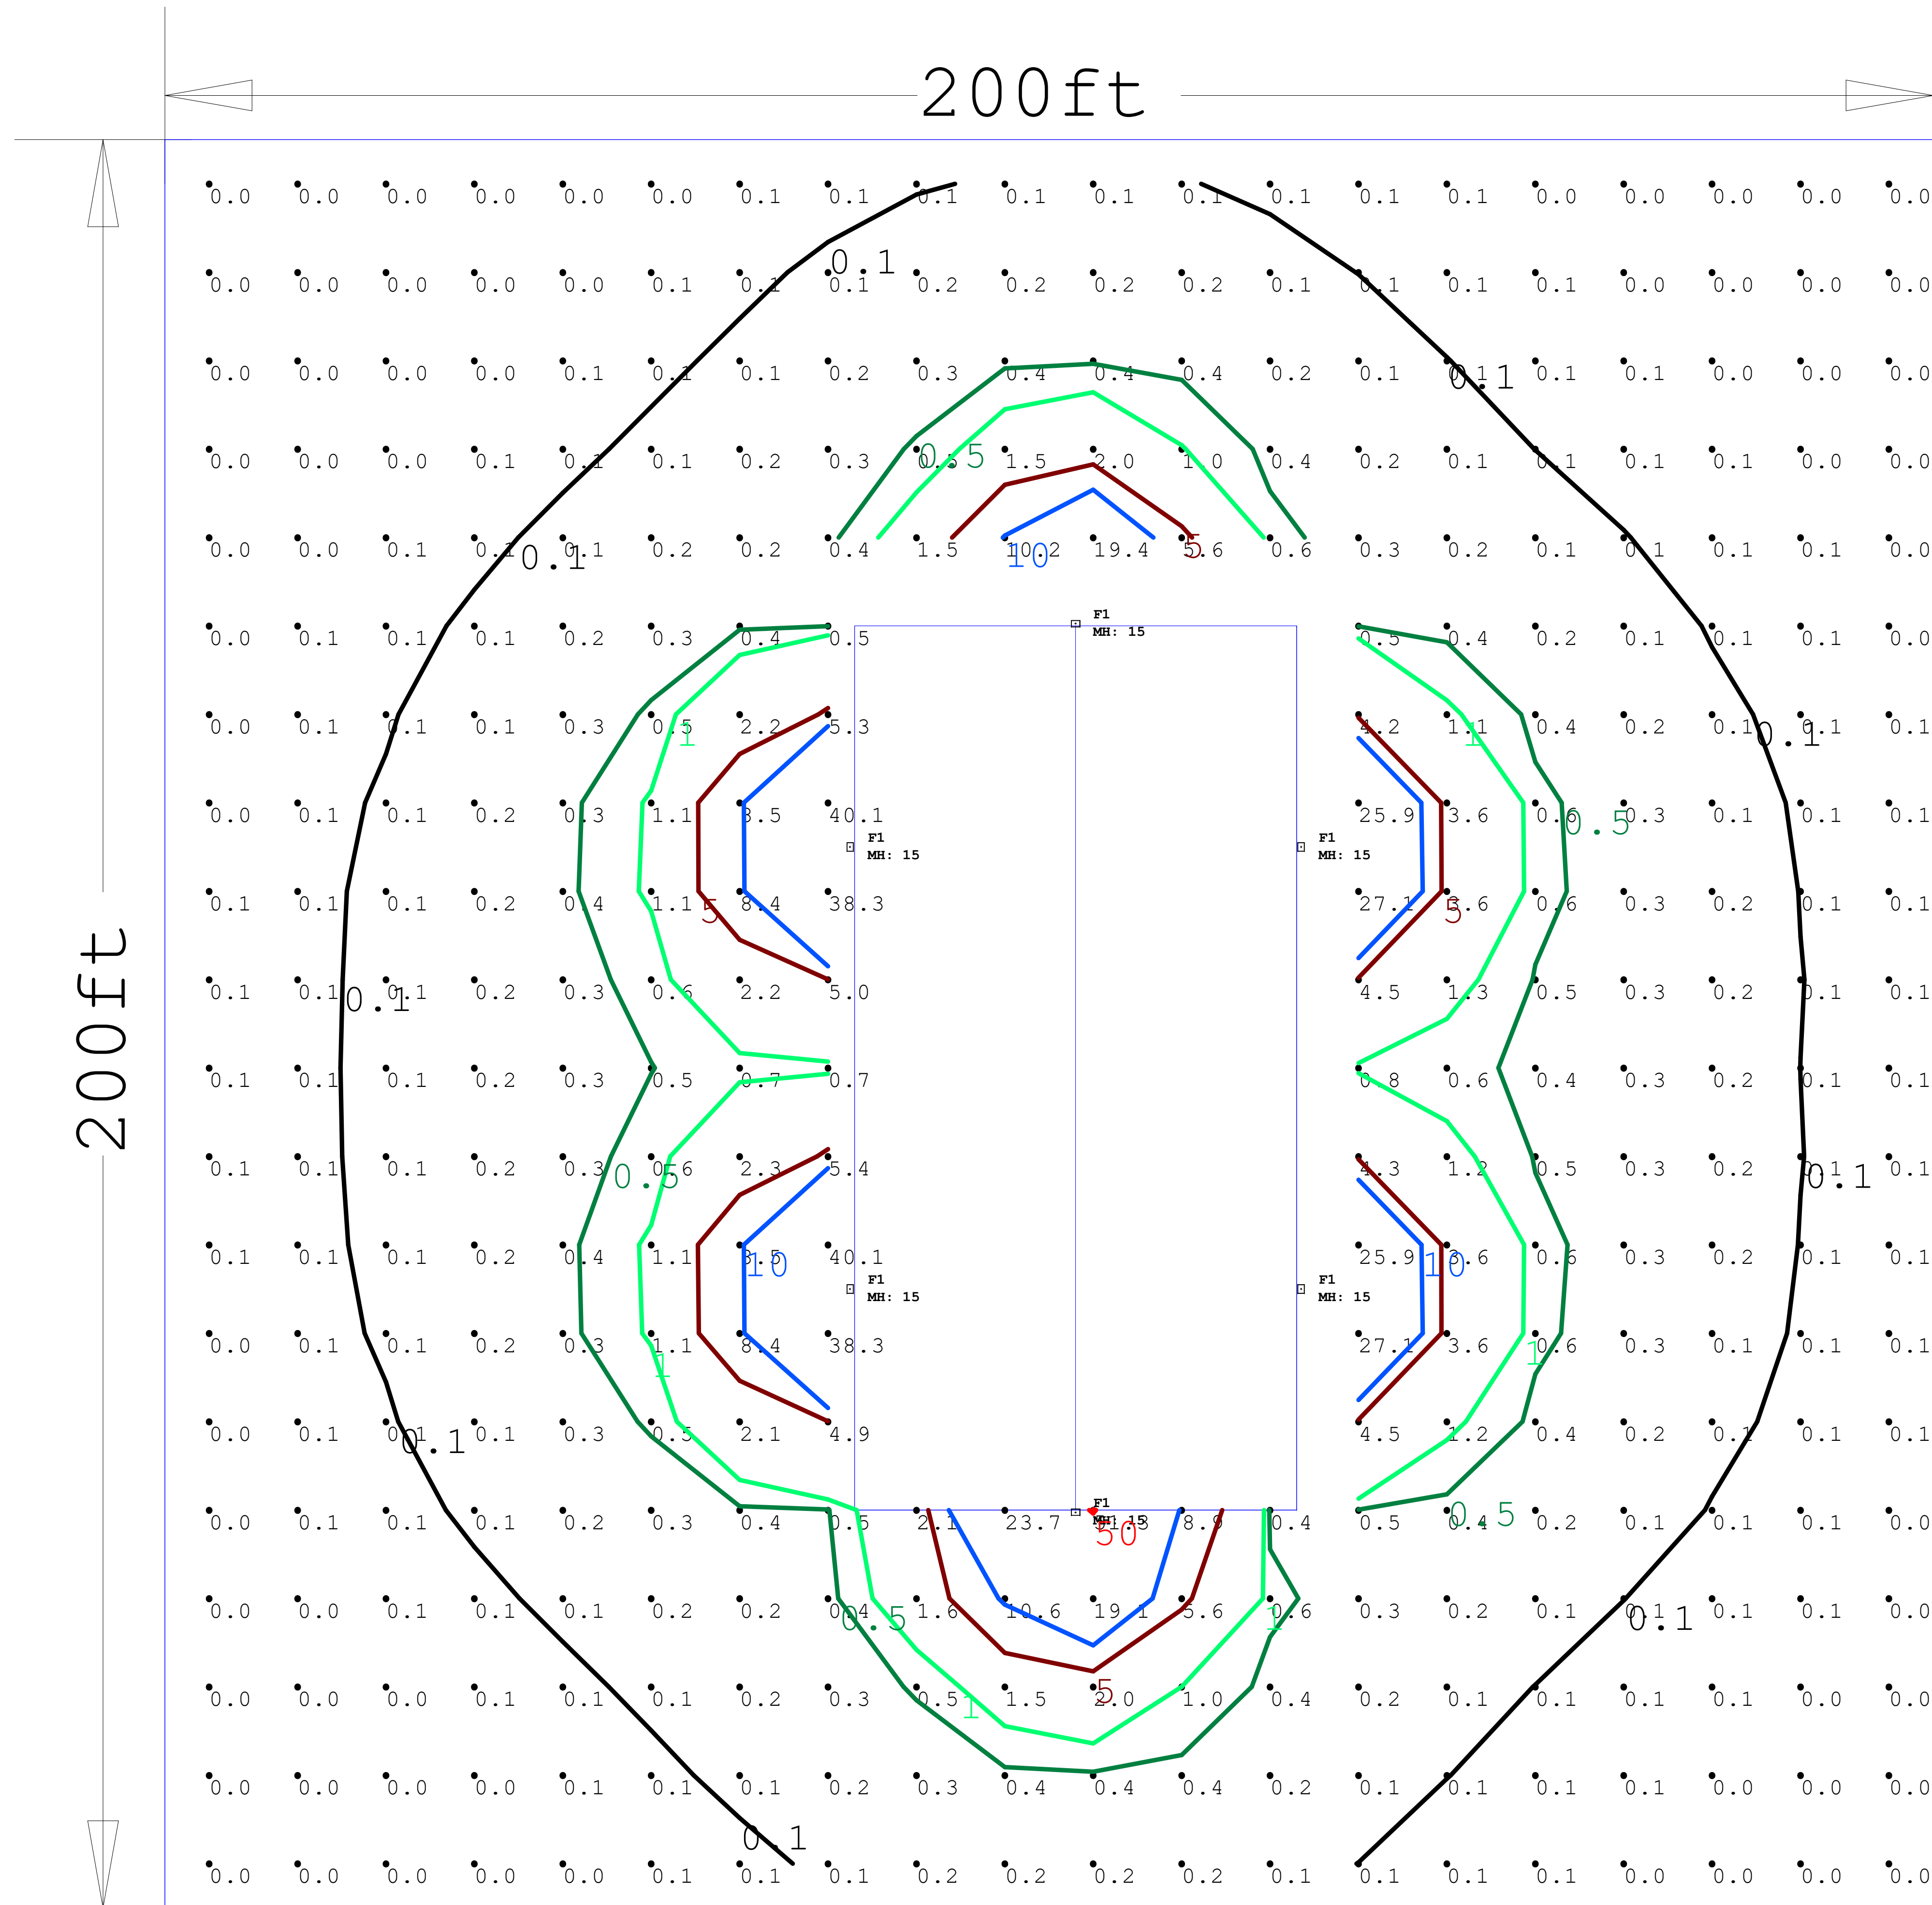


**LIGHTING DETAILS:**

Luminaire Schedule						
Label	Symbol	Qty	LLF	Description	Luminaire Lumens	Luminaire Watts
F1		6	1.000	RGL-RWP02-120W	14513	113.34

Calculation Summary						
Label	CalcType	Units	Avg	Max	Min	Max/Min
Object_2_Top_1	Illuminance	Fc	1.67	51.3	0.0	N.A.



# 120 WATT ROTATE

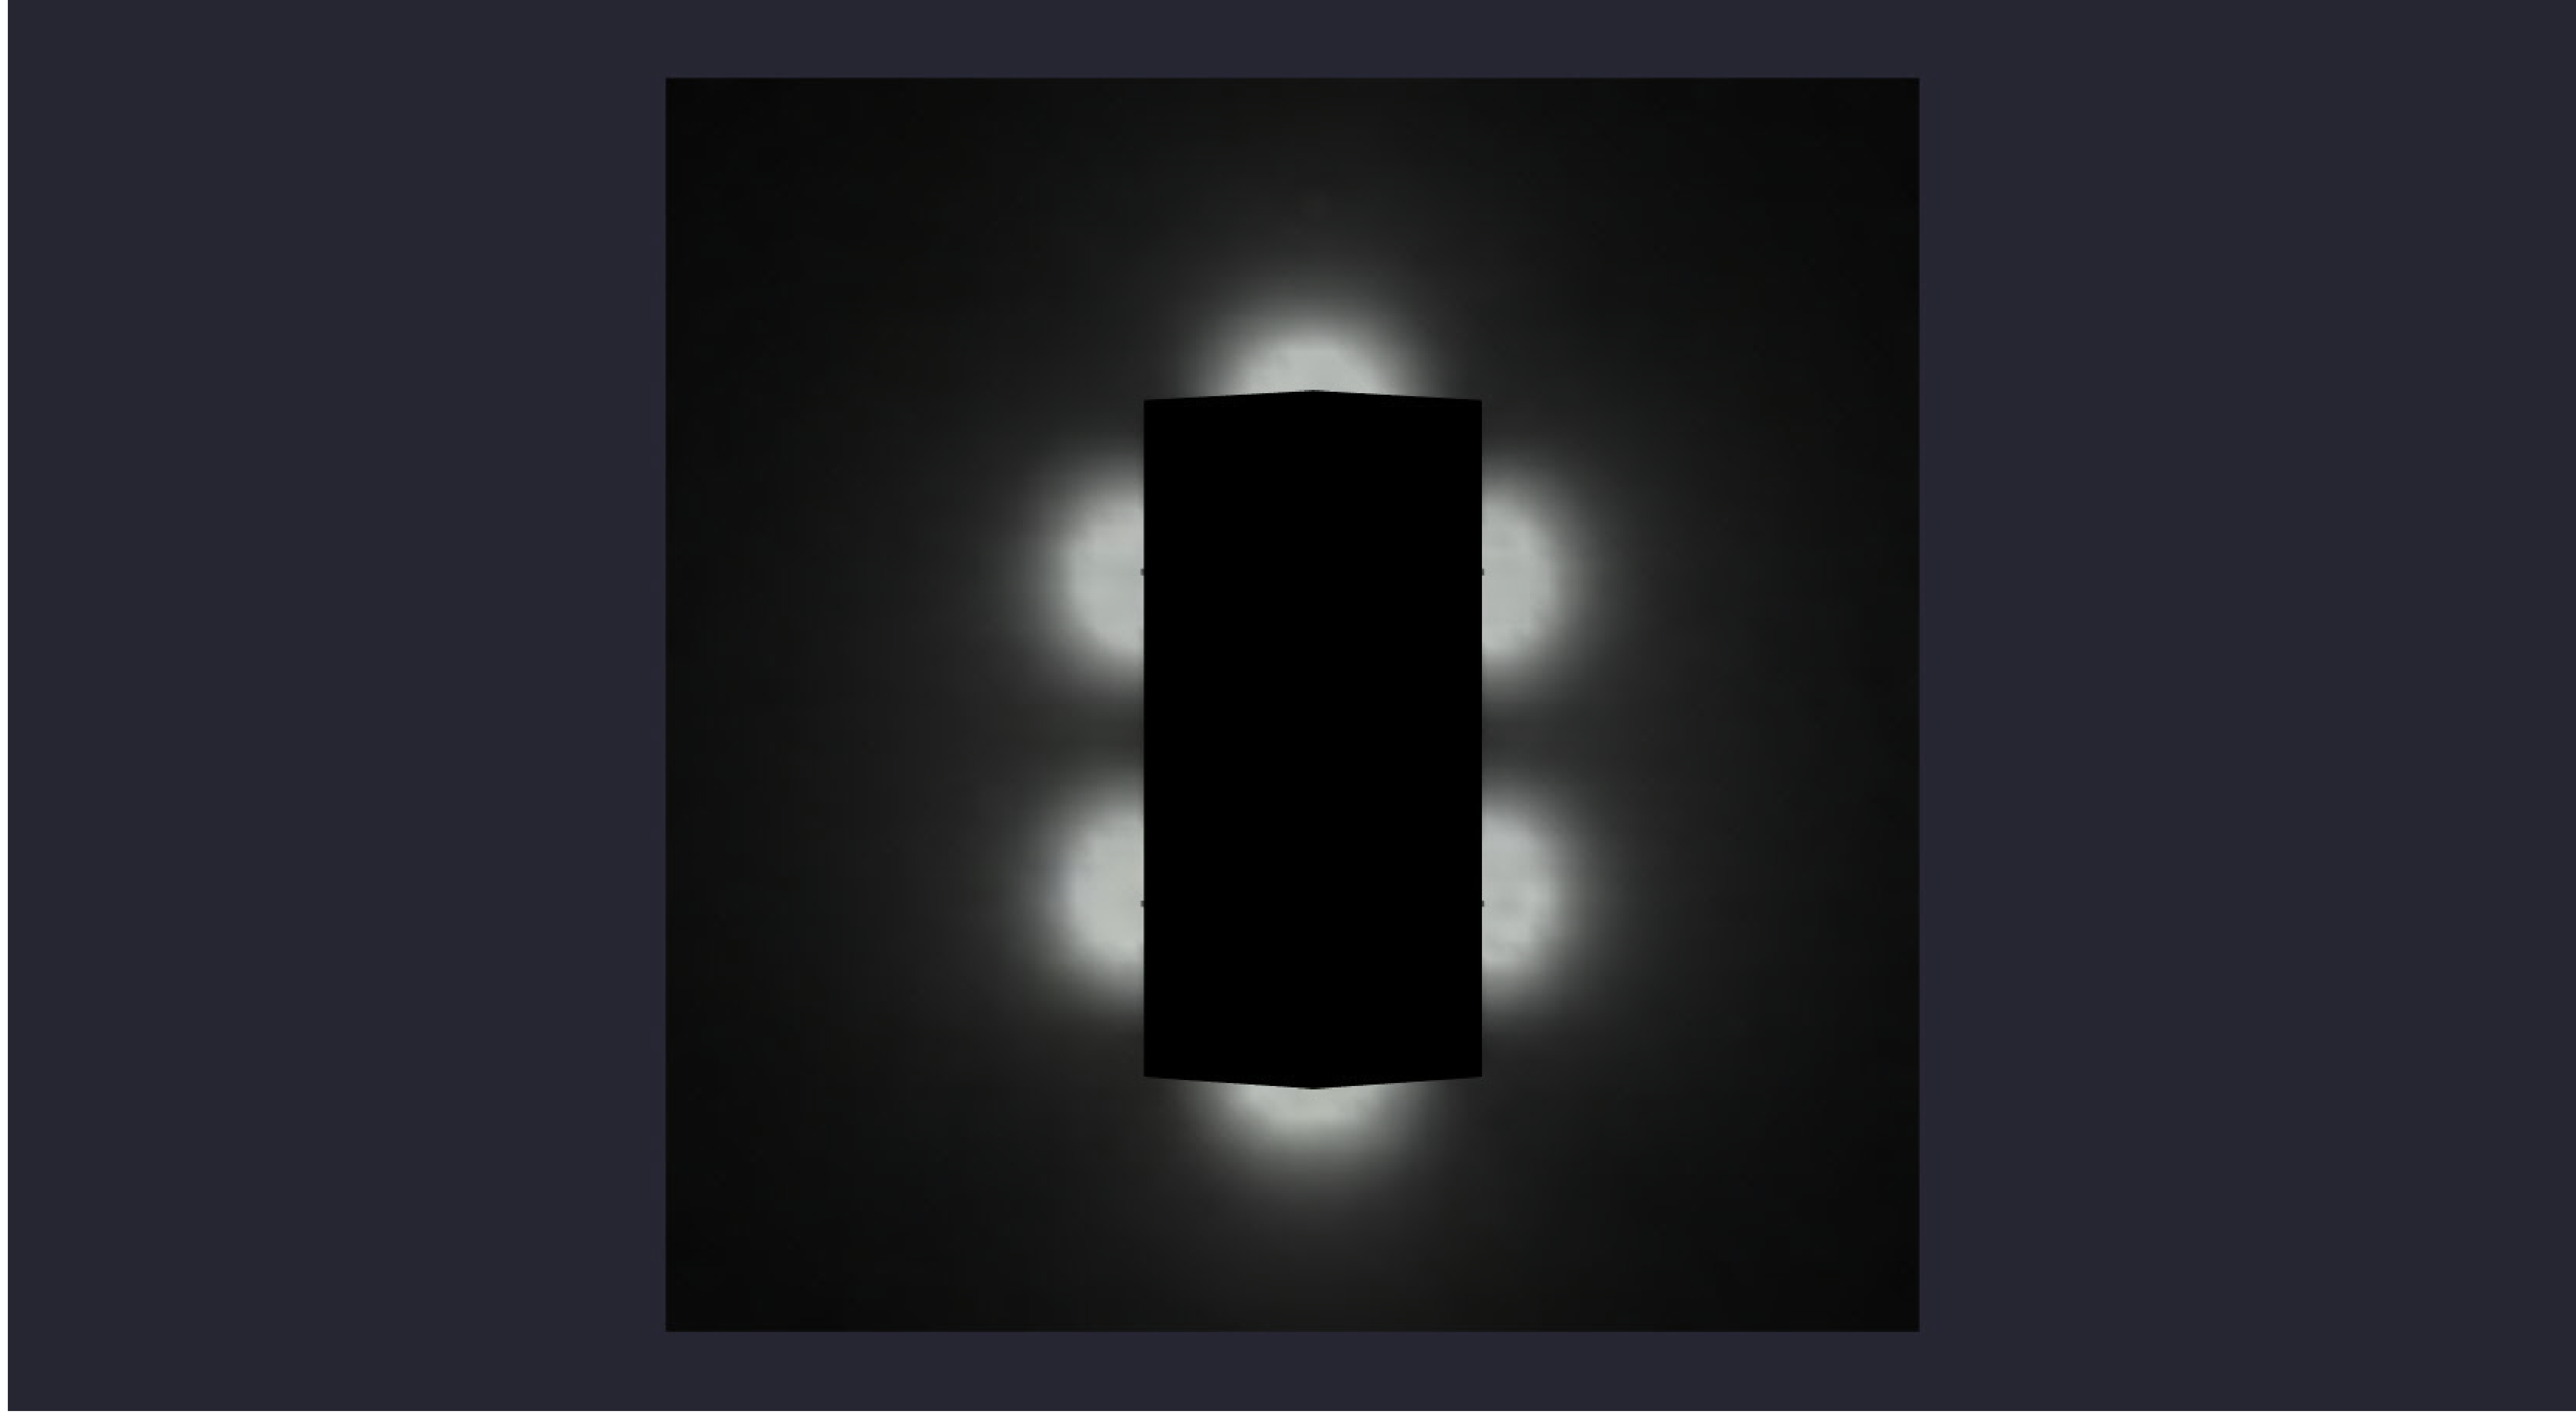


Date:9/11/2025

Drawn By:

Revision #:

## 120 WATT ROTATE

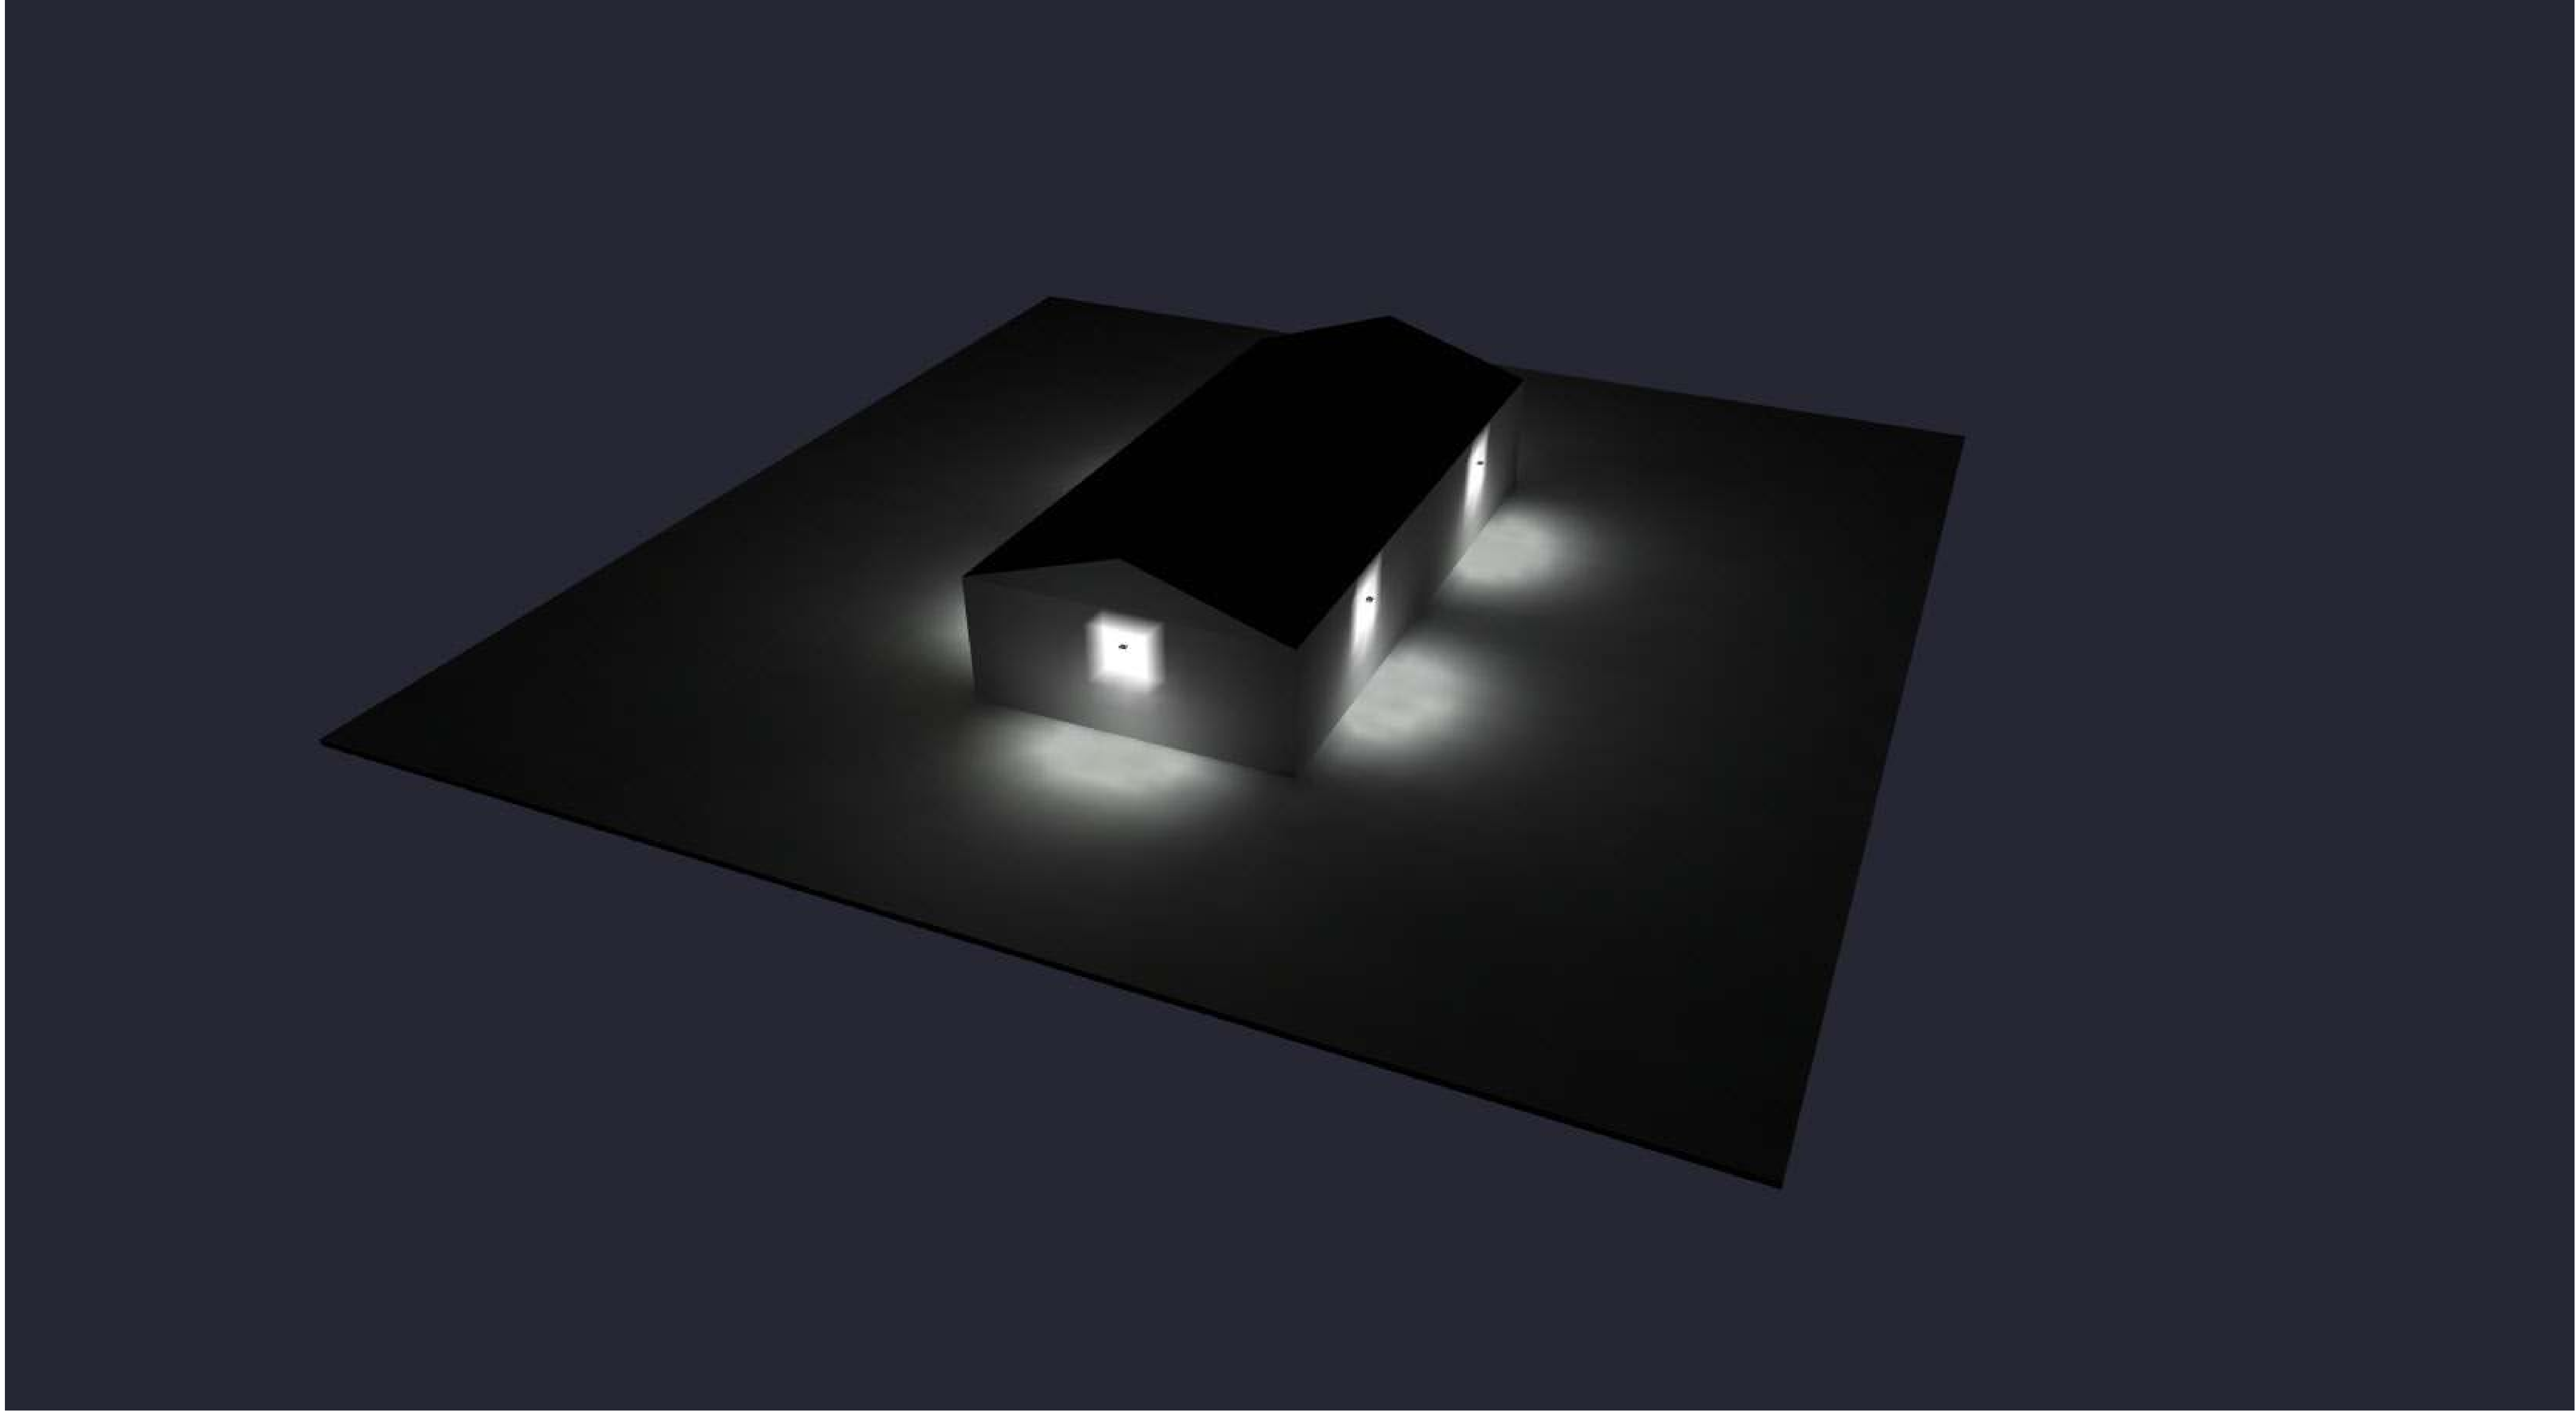


Date:9/11/2025

Drawn By:

Revision #:

## 120 WATT ROTATE

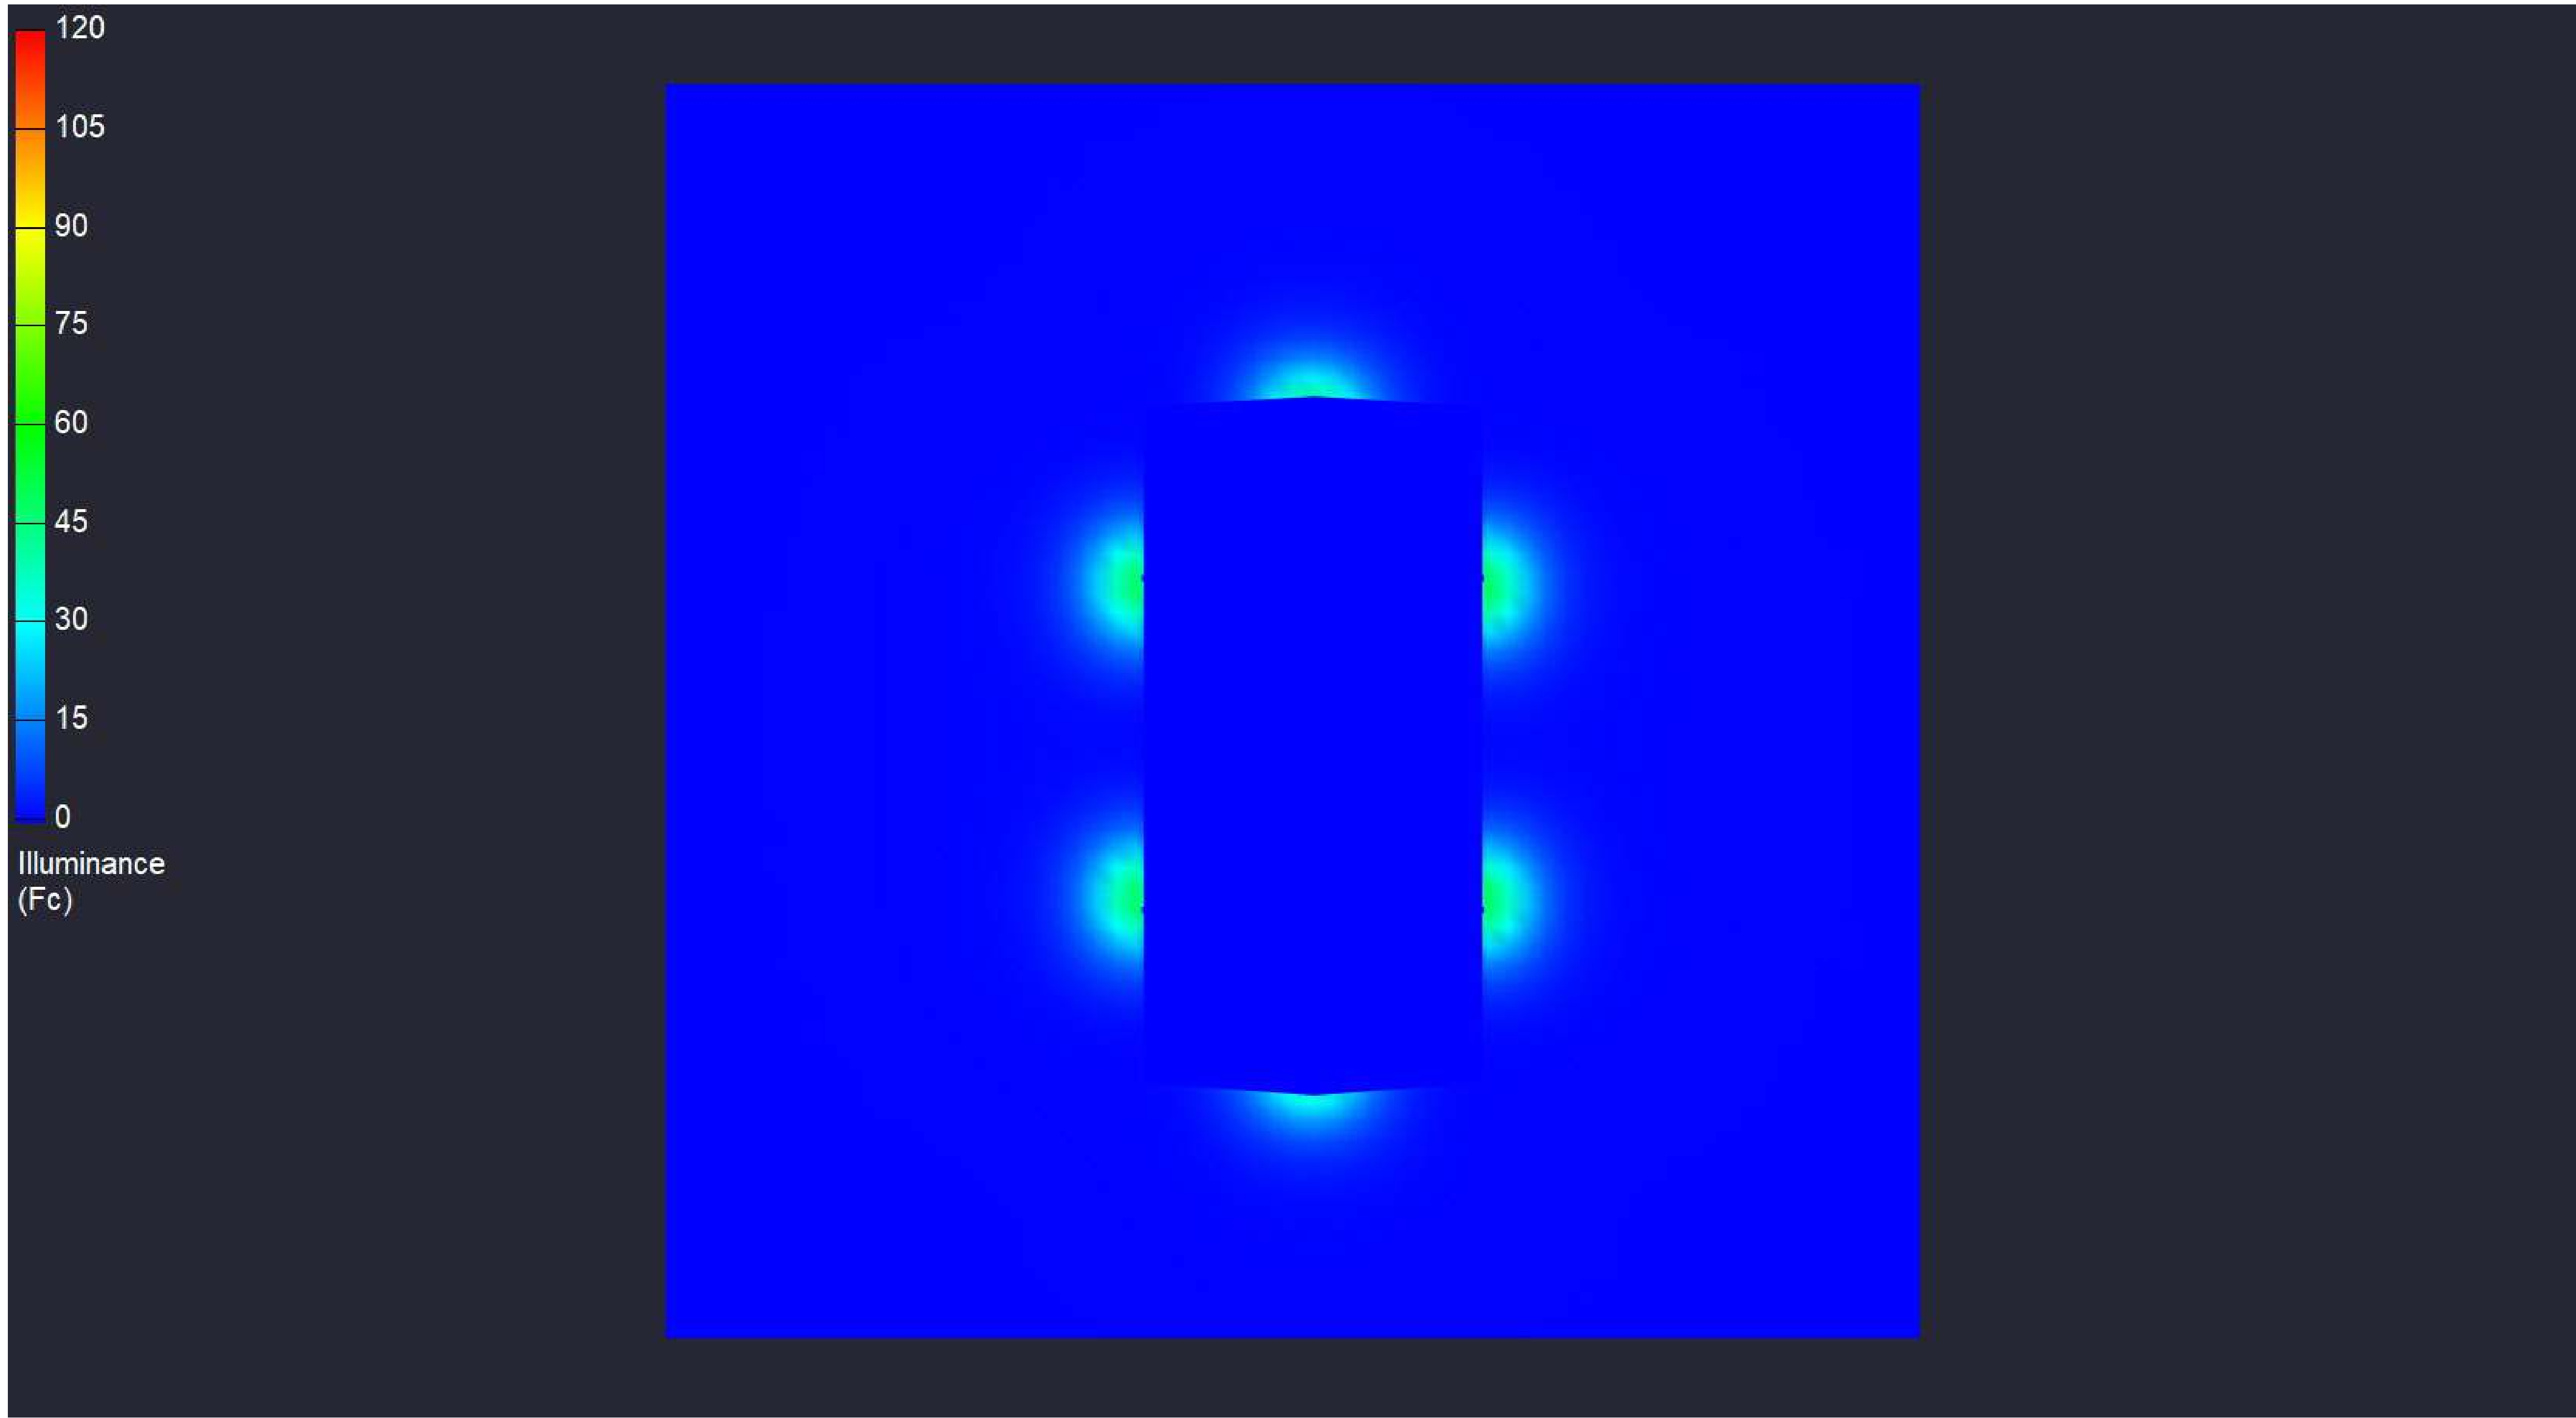

# 120 WATT ROTATE

Date:9/11/2025

Drawn By:

Revision #: