


Statistical Area
 Illuminance (Fc)
 Average = 3.94
 Maximum = 12.6
 Minimum = 0.4
 Avg/Min Ratio = 9.85
 Max/Min Ratio = 31.50

Luminaire Schedule						
Symbol	Qty	Description	LLF	Luminaire Lumens	Luminaire Watts	Total Watts
⊖	1	STADIUM PRO -5-500W-40D	1.000	83264	499.165	499.165

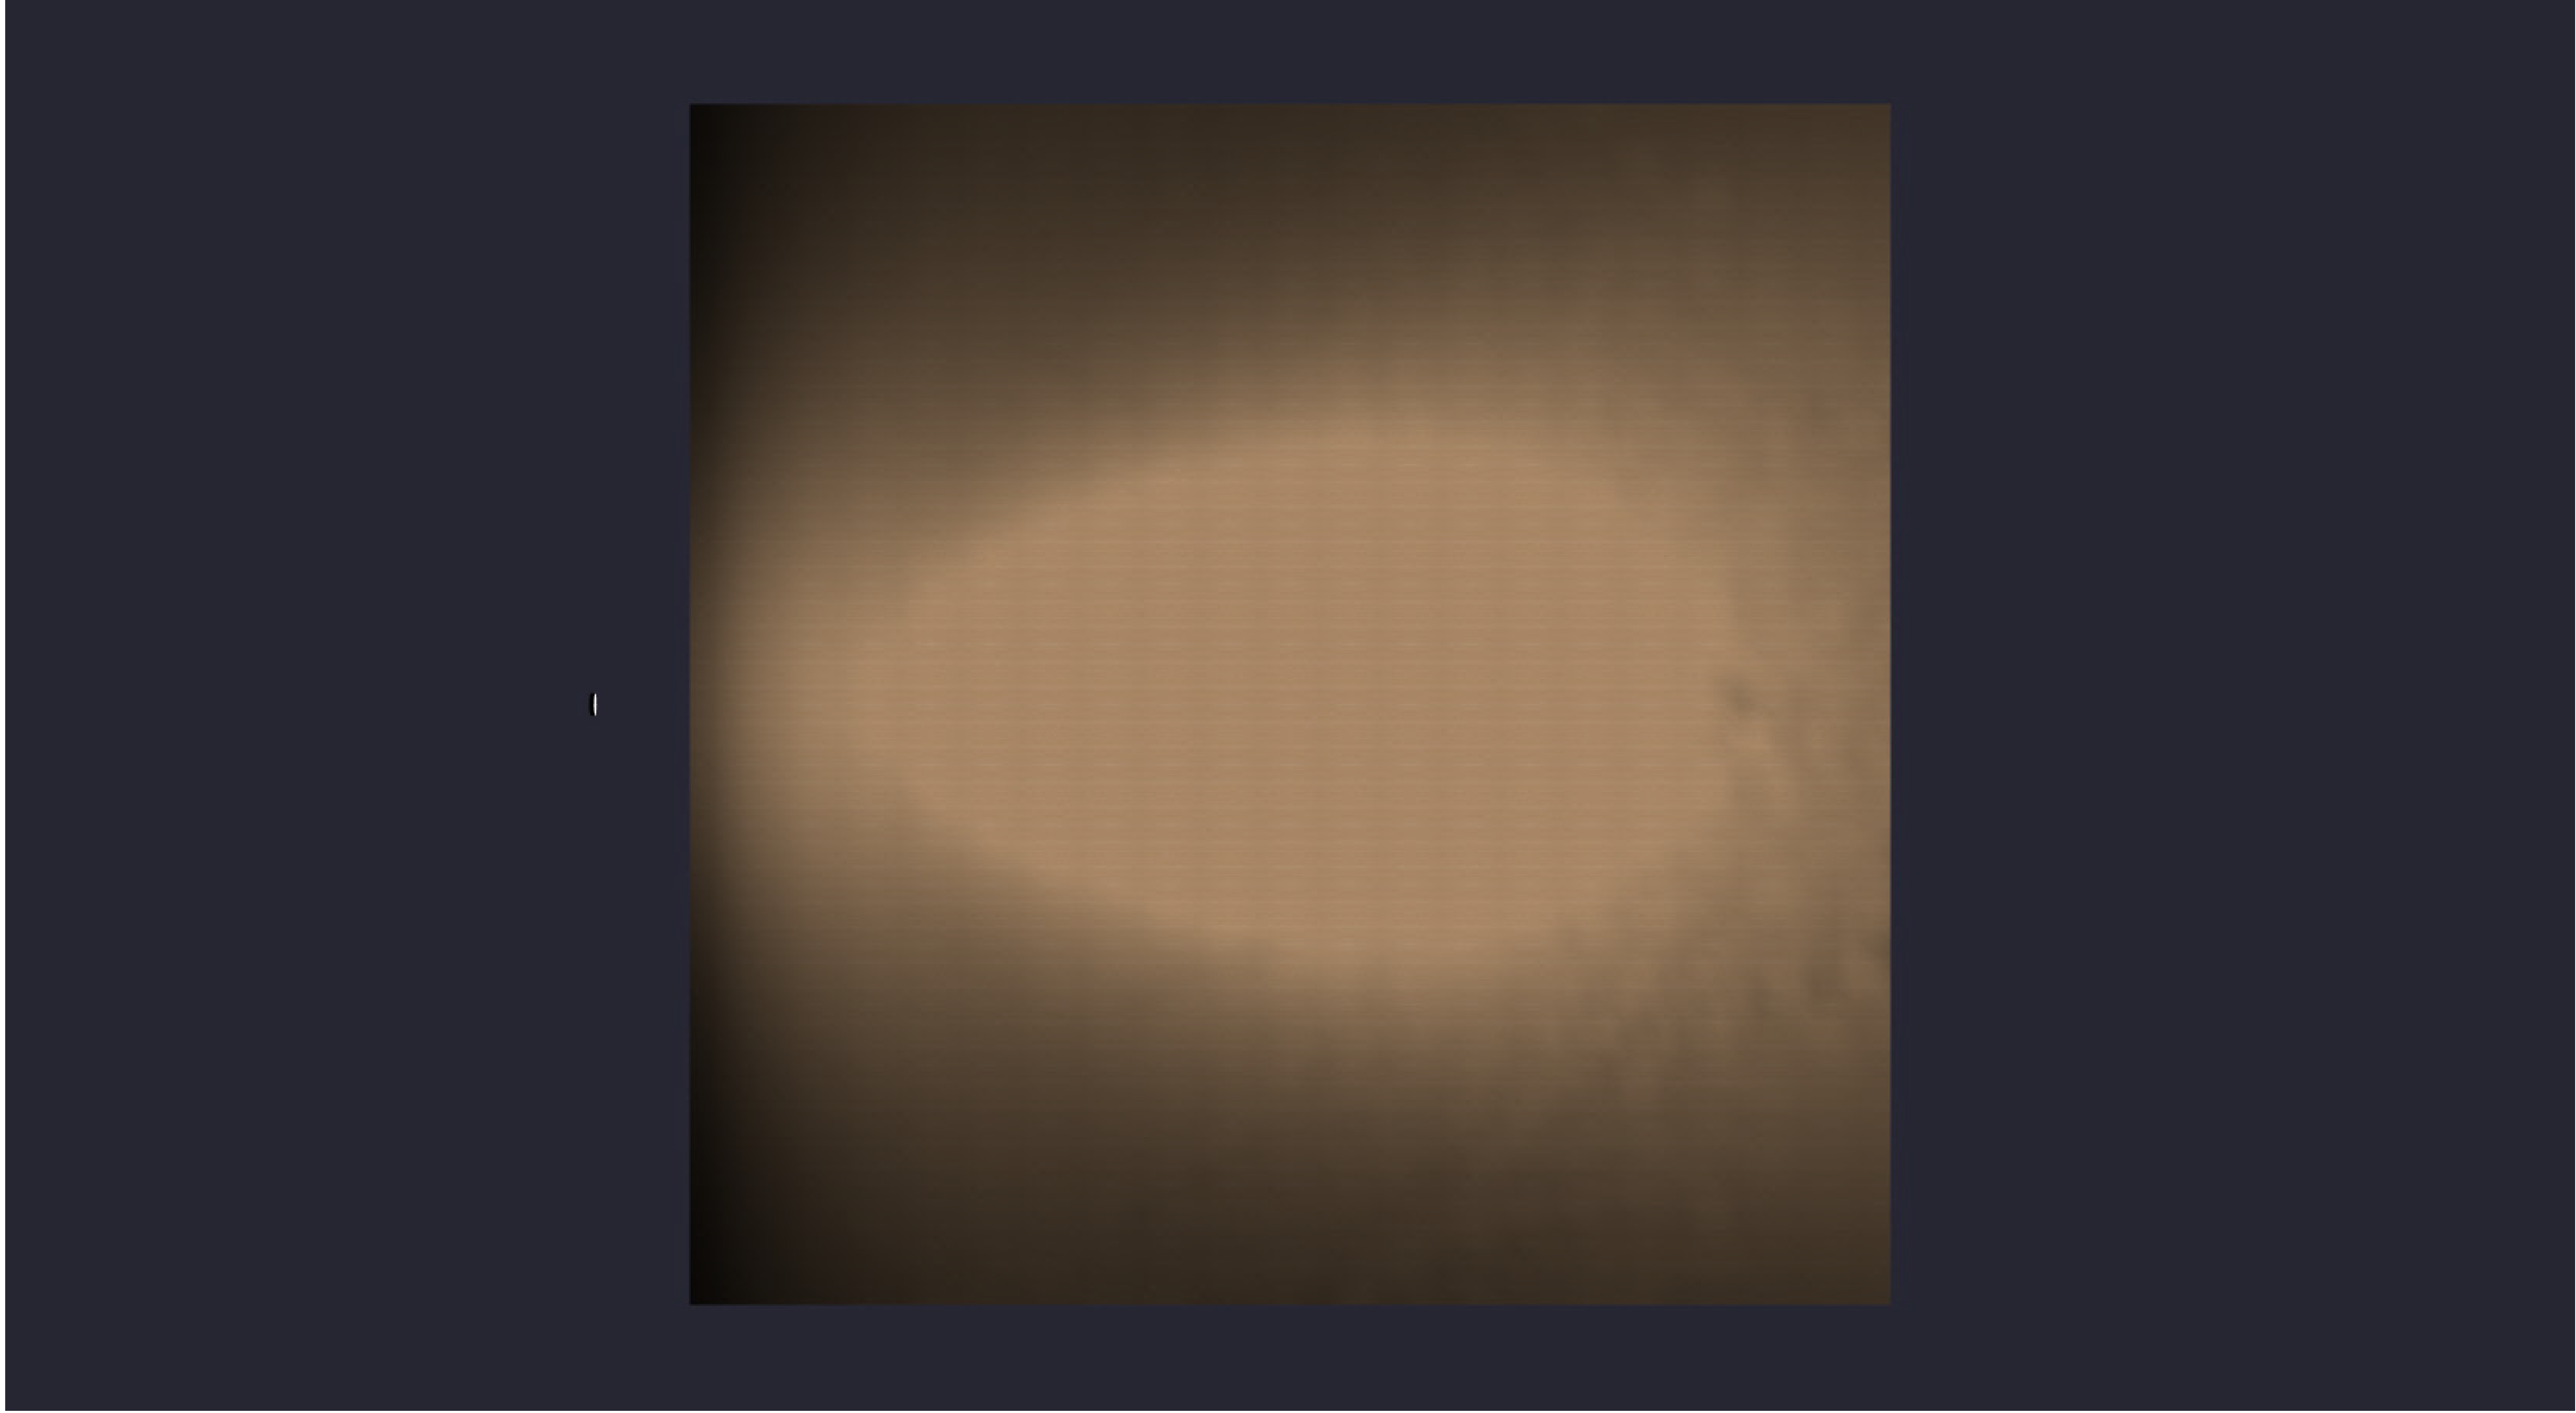


Date:12/19/2025

Drawn By:

Revision #:

82-165 1-STADIUM PRO-5-500W 50' MTG

 LEDLightExpert.com

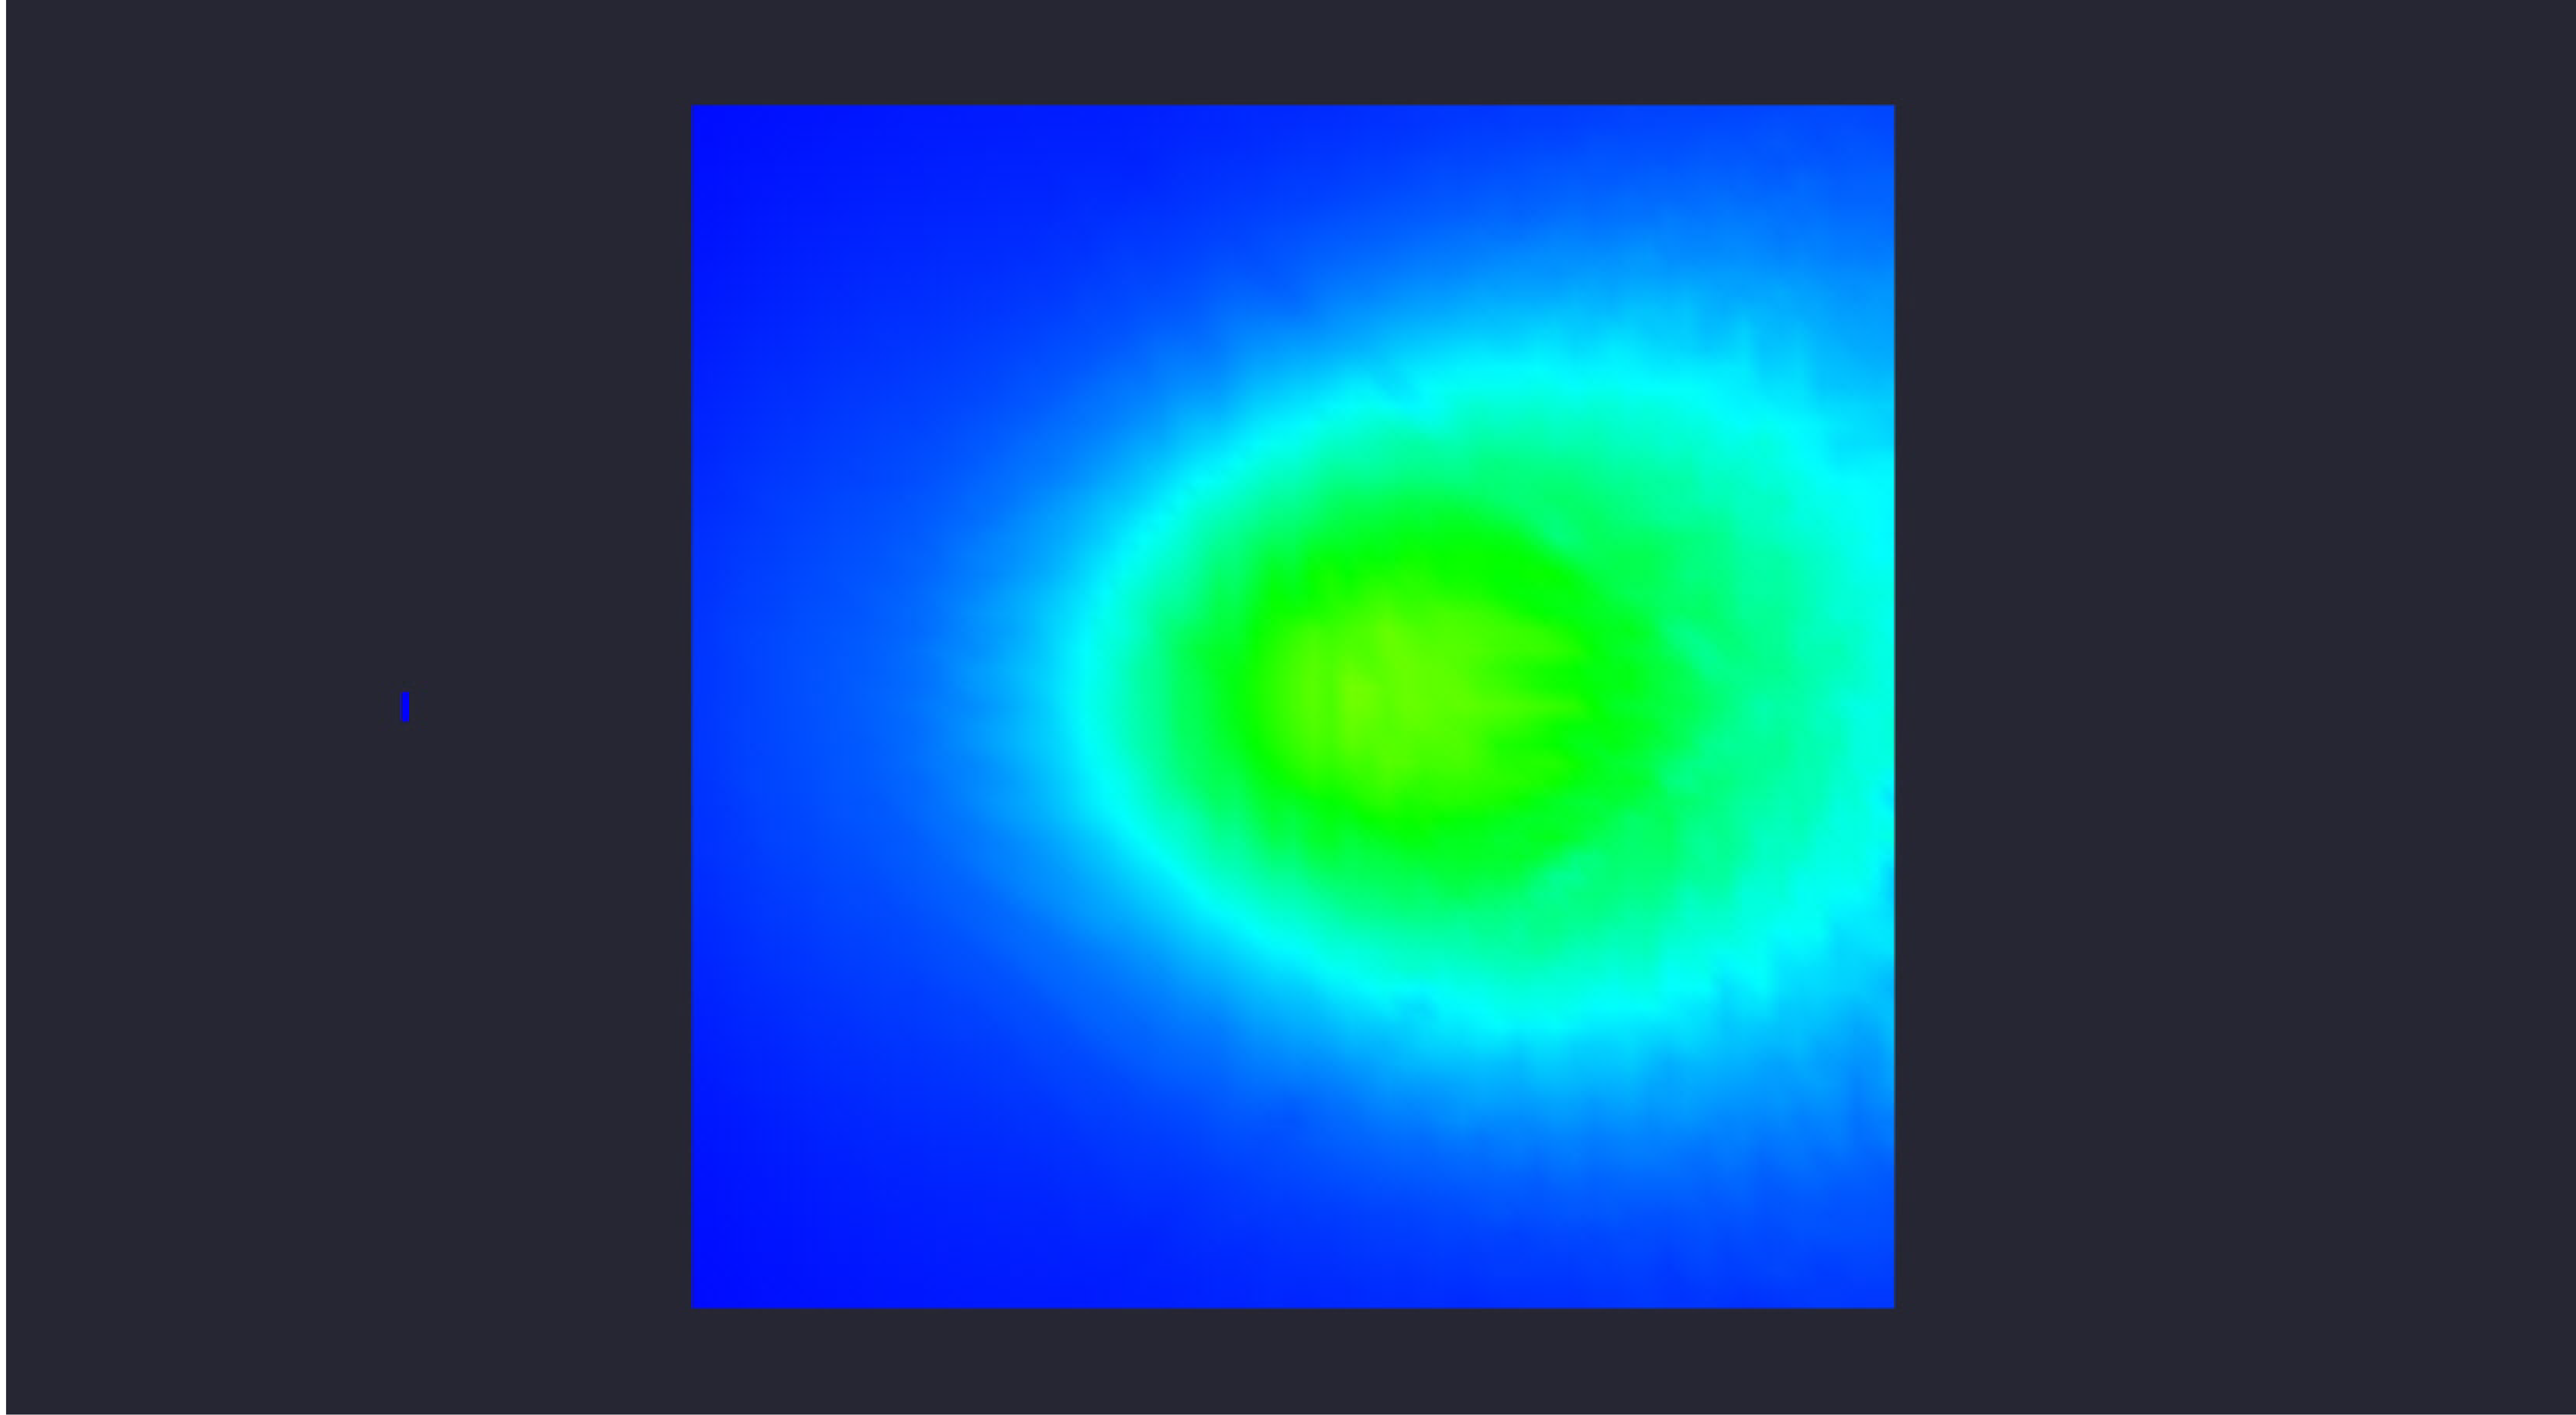

Date:12/19/2025
Drawn By:
Revision #:

82-165 1-STADIUM PRO-5-500W 50' MTG